

THIS DRAWING IS THE PROPERTY OF MK CE Ltd AND AS SUCH MAY NOT BE COPIED OR COMMUNICATED TO A THIRD PARTY WITHOUT WRITTEN AUTHORISATION

General Notes

- 1.00 THE CONTRACTOR SHALL BE RESPONSIBLE FOR CO-ORDINATION, DESIGN OF BRACKETS, SUPPORT WORK AND BUILDERSWORK
- 2.00 INSTALL AND CERTIFY THE WORKS IN ACCORDANCE WITH INDUSTRY STANDARD HEALTH & SAFETY & BUILDING CONTROL REQUIREMENTS
- 3.00 THE MECHANICAL CONTRACTOR SHALL SET TO WORK THE WHOLE OF THE INSTALLATIONS, FULLY COMMISSION THE SYSTEMS, IN ACCORDANCE WITH ALL INDUSTRY STANDARDS, BUILDING CONTROL, CLIENT REQUIREMENTS AND GOOD PRACTICE
- 4.00 THE CONTRACTOR SHALL SUBMIT RISK ASSESSMENTS AND METHOD STATEMENTS TO PROJECT MANAGER FOR ALL ELEMENTS OF THE WORKS PRIOR TO WORKS TAKING PLACE
- 5.00 THE CONTRACTOR SHALL SUBMIT DIMENSIONED WORKING DRAWINGS & TECHNICAL SUBMISSIONS FOR APPROVAL TO THE PROJECT MANAGER FOR ALL ELEMENTS OF THE WORKS PRIOR TO PROCUREMENT AND INSTALLATION OF THE WORKS

Contractors' Coordination Responsibility

THE INFORMATION ON THIS DRAWING IS FOR ACE LEVEL ABRIDGED DESIGN DUTY PURPOSES ONLY.


THE CONTRACTOR SHALL PREPARE & SUBMIT DIMENSIONED & FULLY COORDINATED WORKING INSTALLATION DRAWINGS FOR APPROVAL PRIOR TO PROCUREMENT.

THE CONTRACTOR IS RESPONSIBLE FOR FULL COORDINATION & SHALL COORDINATE MECHANICAL, ELECTRICAL, STRUCTURAL, REFLECTED CEILING PLAN & ARCHITECTURAL ELEMENTS OF THE PROJECT.


Important Specification Note

READ ALL NOTES, SCHEDULES & INSTALLATION INSTRUCTIONS ON THIS DRAWING.


NOTES, SCHEDULES AND INSTRUCTIONS FORM PART OF THE SPECIFICATION FOR THE WORKS, AND MAY NOT BE REPEATED IN THE WRITTEN SPECIFICATION.

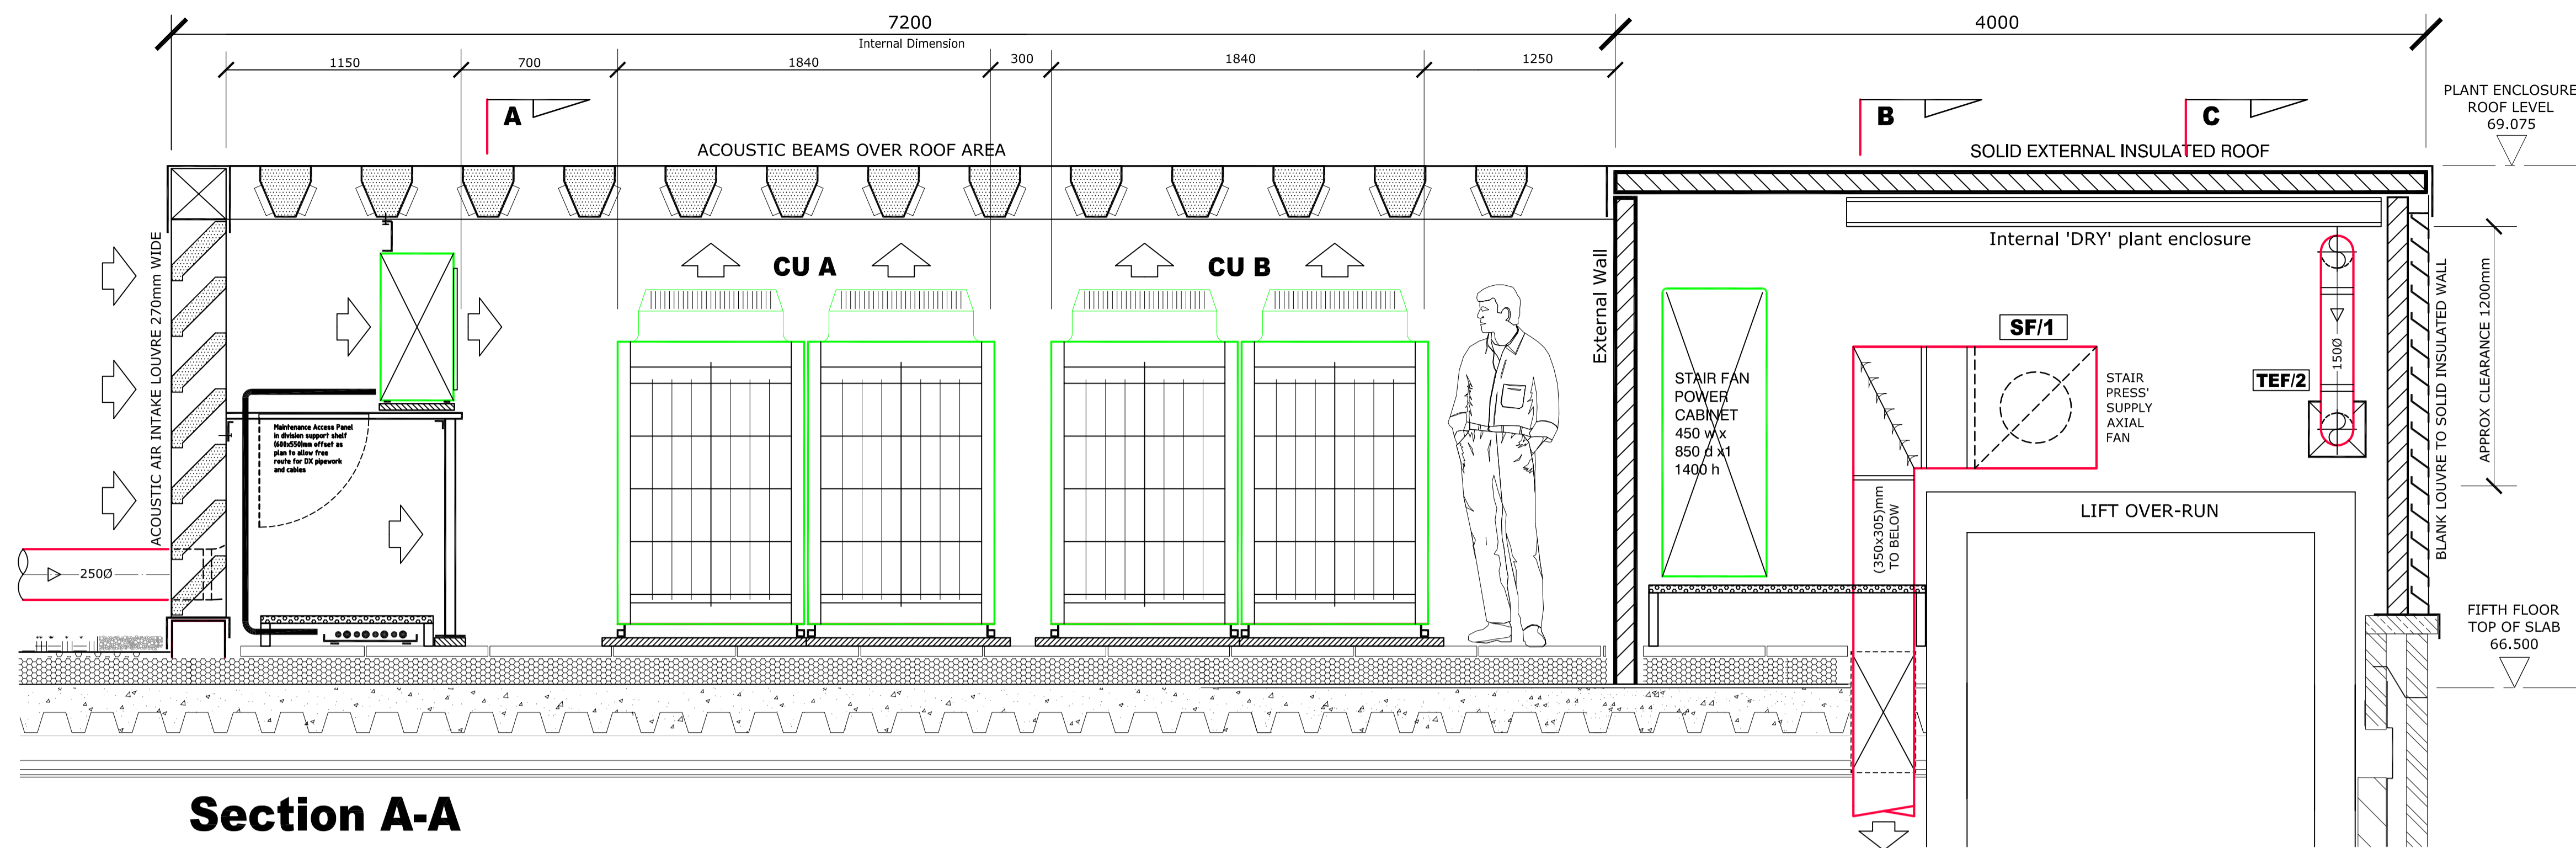

Section A-A

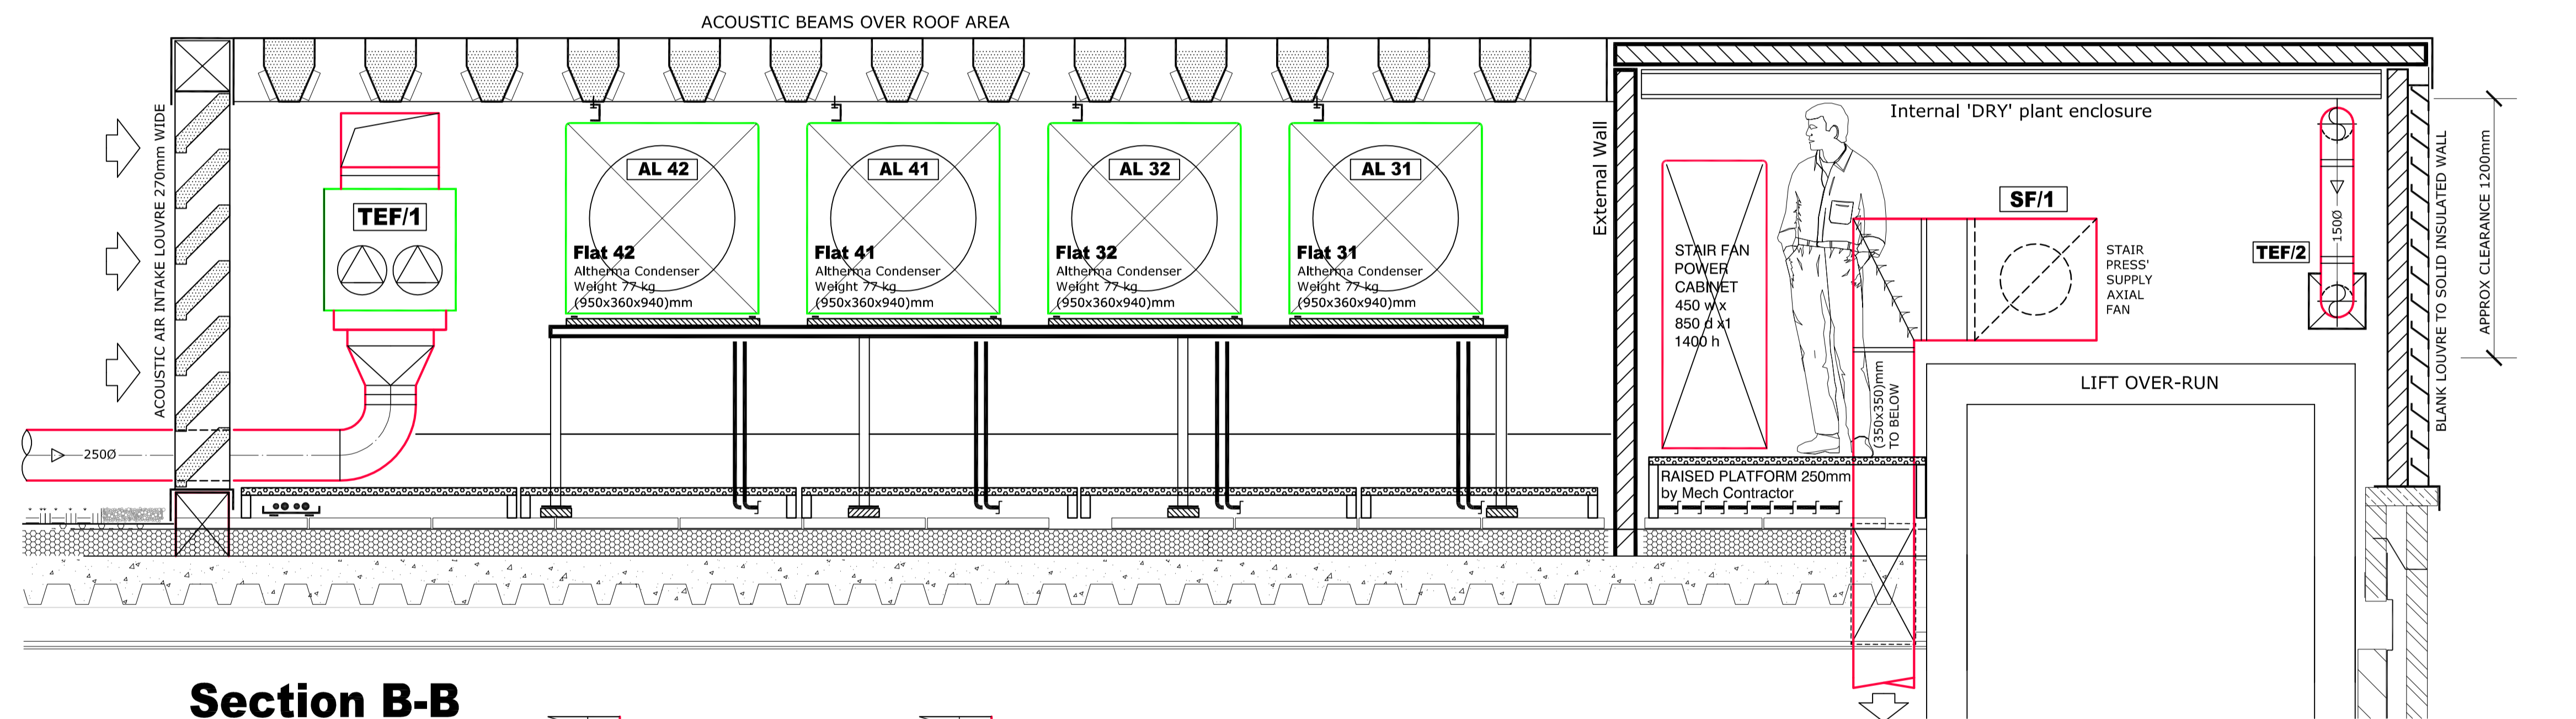

Section B-B

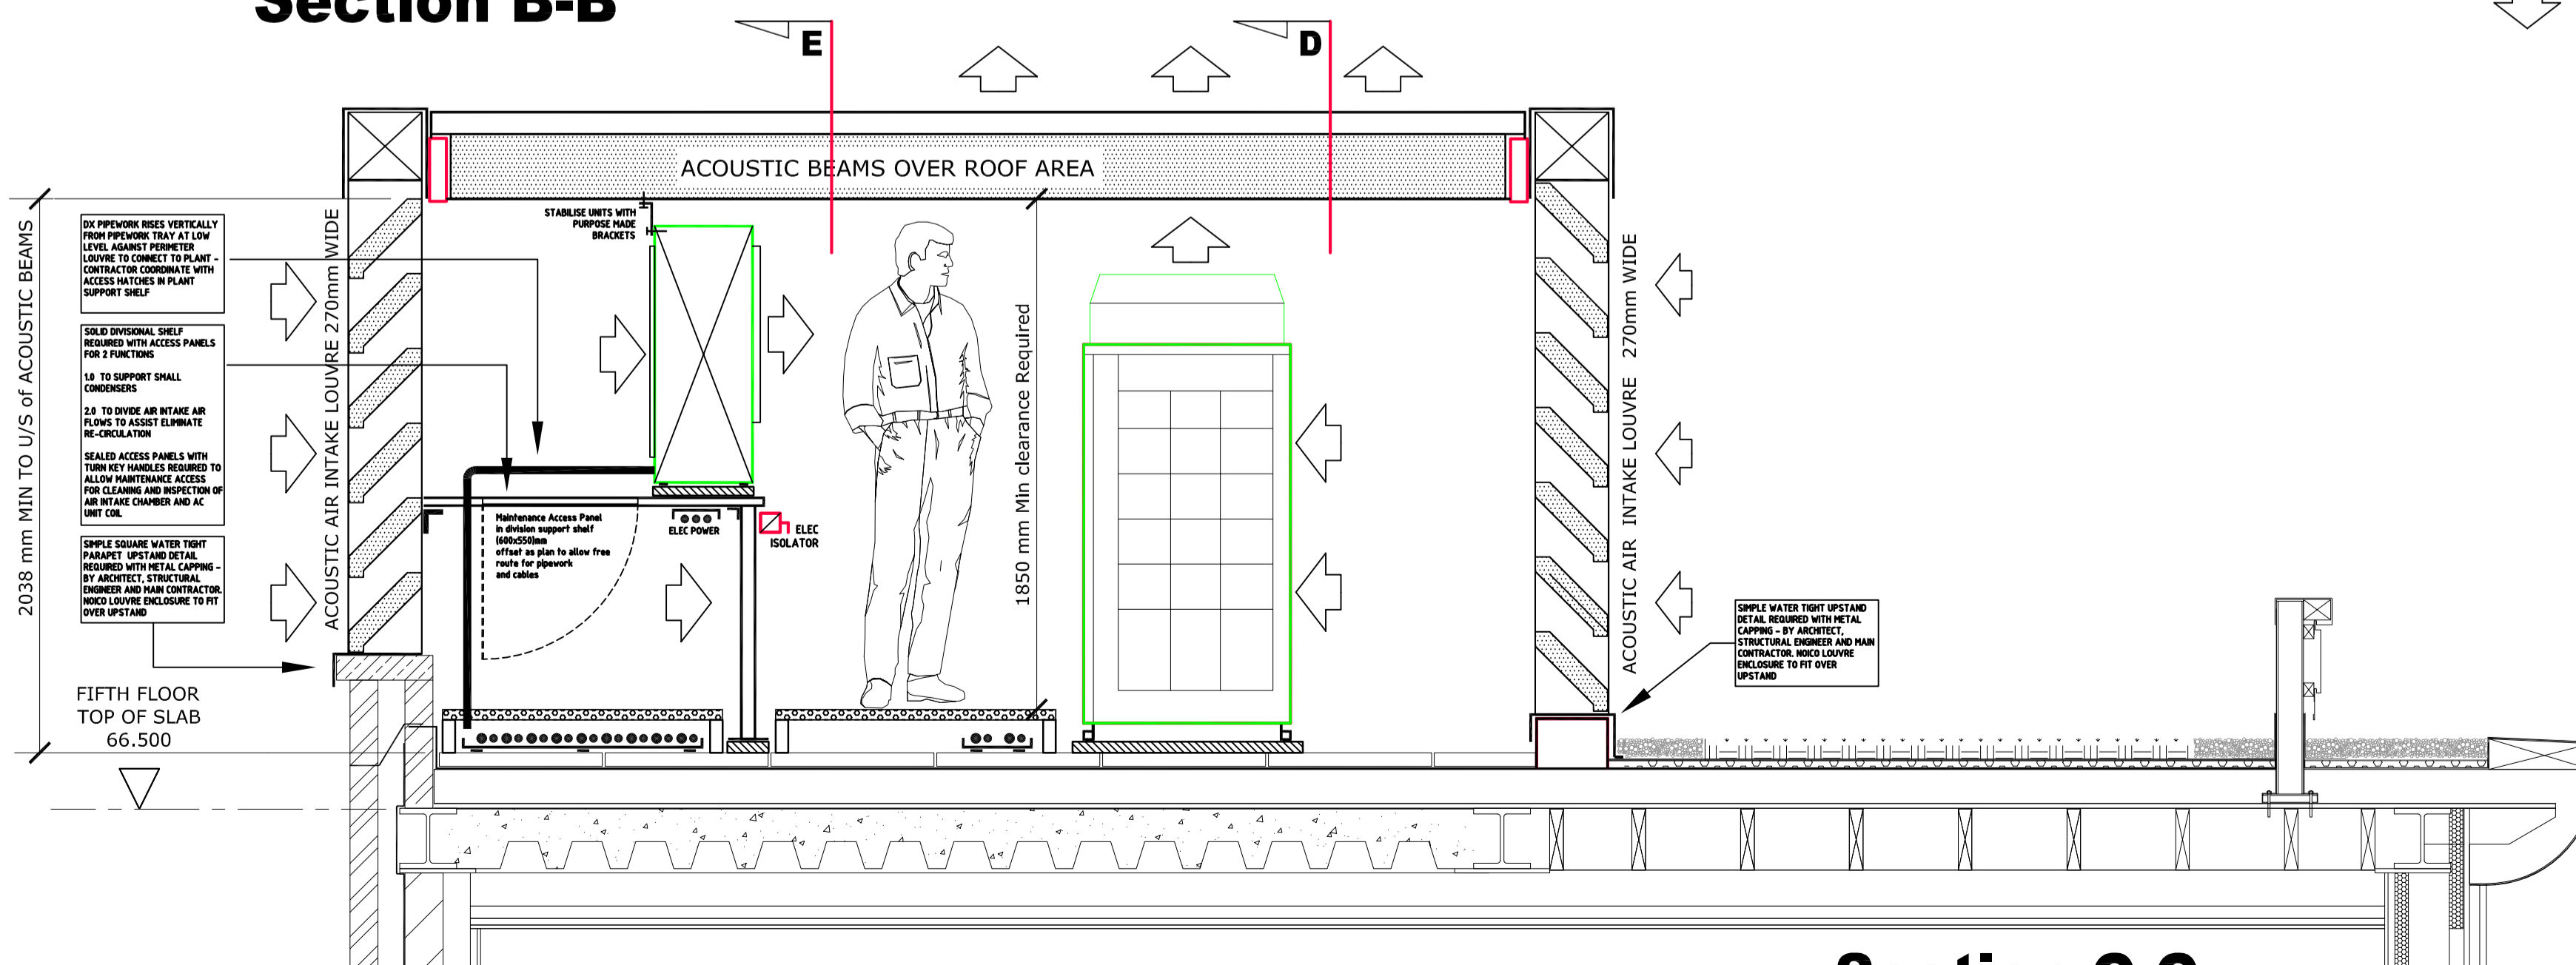

Section C-C

Acoustic Plant Enclosure Sections
Scale 1:10 @ A1

C	CONTRACT ISSUE	1/11/2012
T	TENDER ISSUE	13/06/2011
Rev	Description	Date

client THE CHARTERED INSTITUTION OF WATER AND ENVIRONMENTAL MANAGEMENT
CIWEM

project manager CS2 Ltd

architect NASH Partnership

project 106-109 SAFFRON HILL, LONDON EC1N 8QS

MK
MK Consulting Engineers Ltd
Building Services Engineering Design & Draughting
Tel: 07702 364 607 E Mail: mkcad99@aol.com

Drawing Title
MECHANICAL SERVICES
ROOF LEVEL PLANT AREA
SECTION A-A

Scale 1:10 @ A1 Drawn AK
Date JUNE 2011 Checked AK

Drawing Number MK/703/SAMPLE Revision C

Drawing Status CONTRACT ISSUE